

\\synology\public\CAD\\$\$\$CUSTOMER\BLUEPRINTS\2024\Metal\4-12\Nicholson, Kelsey (BLDG-40-34-10-MTL-4-12)\COVER - NICHOLSON WUI.dwg

REVIEWED FOR CODE COMPLIANCE

PERMIT SONOMA
BUILDING PLAN CHECK

Date Stamped 9/4/2024

Permit # BLD24-3841.R01

Plans Examiner Janeen Casebeer

APPROVED PLANS AND DOCUMENTS TO BE AVAILABLE ON THE JOB SITE

BUILDER SHALL NOT DEVIATE FROM THE APPROVED PLANS. REQUESTS FOR CHANGES SHALL BE MADE IN WRITING TO PERMIT SONOMA. CHANGES MADE WITHOUT PRIOR APPROVAL SHALL BE SUBJECT TO REJECTION OF THE WORK.


APPROVAL OF THESE PLANS IS SUBJECT TO, AND DOES NOT AUTHORIZE DEVIATION FROM COMPLETE COMPLIANCE WITH CODE REQUIREMENTS. SPECIAL INSPECTION WHEN REQUIRED, AND FIELD INSPECTION.

PLEASE READ ALL PERTINENT SECTIONS OF APPLICABLE CODES.

SCOPE OF THIS REVISION
IS TO ADD ELECTRICAL TO
THE DETACHED GARAGE.



LEGEND

SYMBOL	DESCRIPTION
---	BOUNDARY LINE
---	EDGE OF DRIVE
-X-X-	FENCE LINE
---	CONTOUR LINE
---	CENTER LINE
~ ~ ~	DRIP LINE
○	TREE TRUNK
⊙	WELL

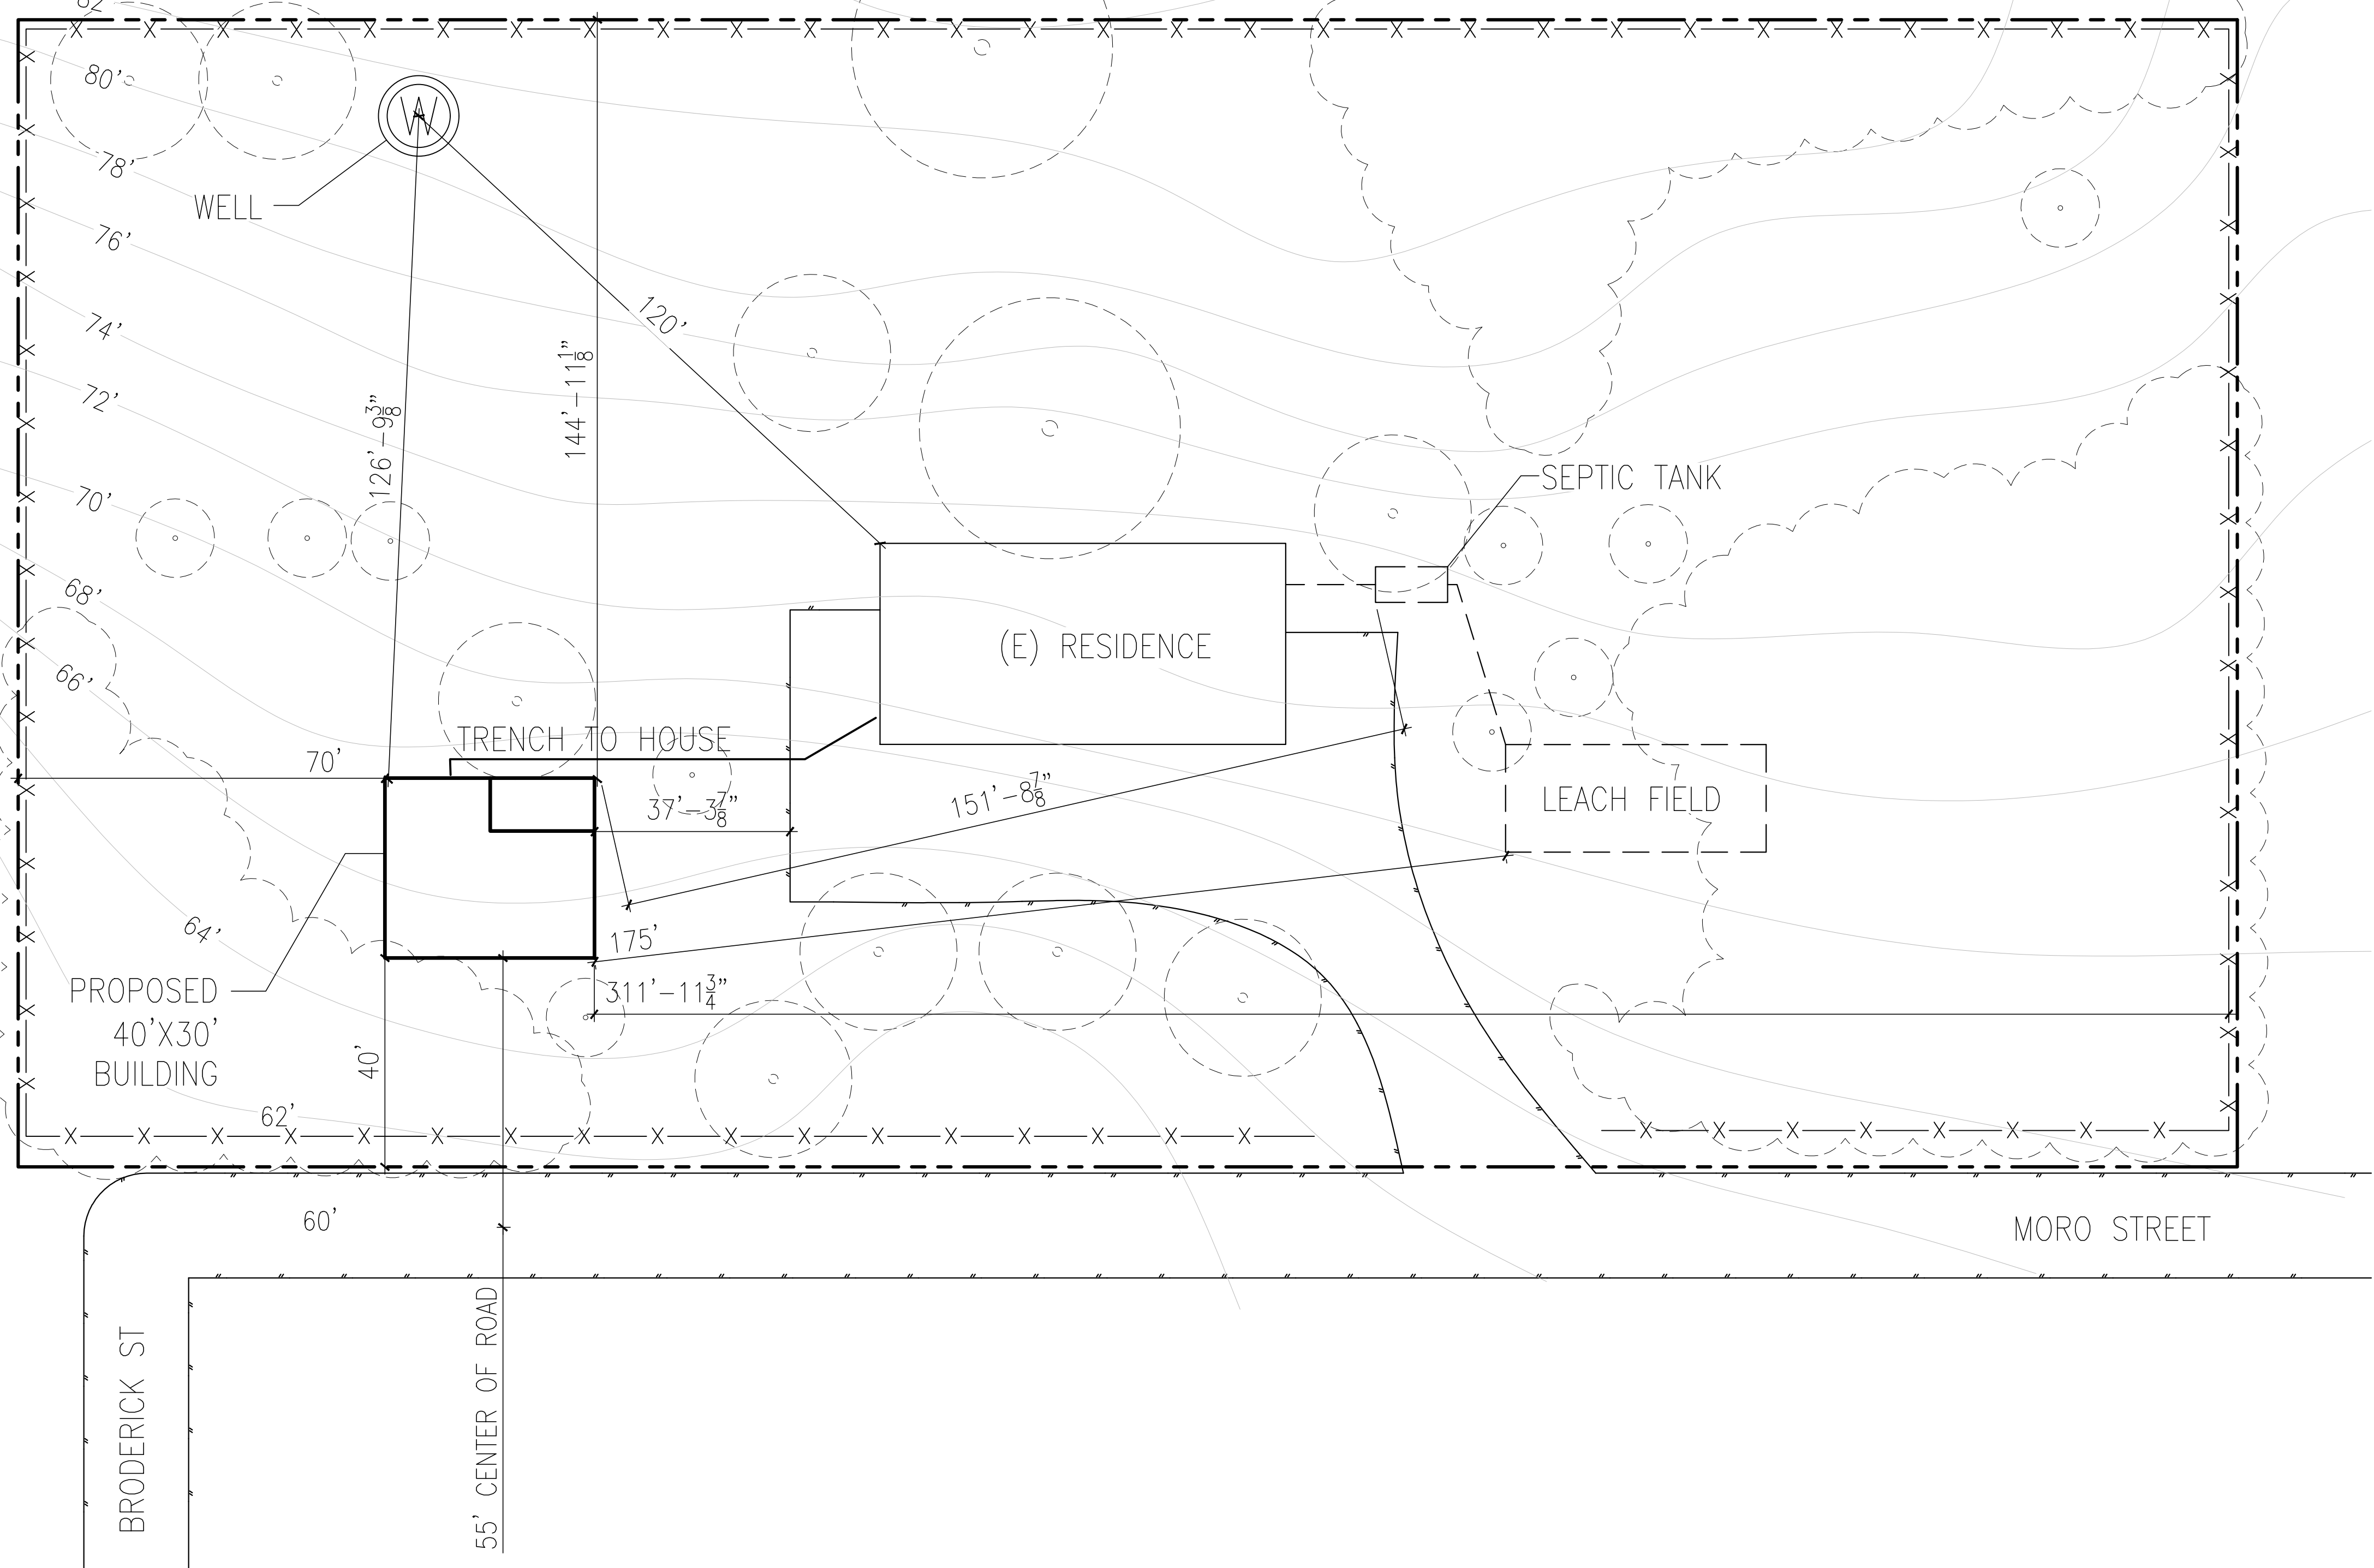

SITE PLAN

 SCALE 1"=20'

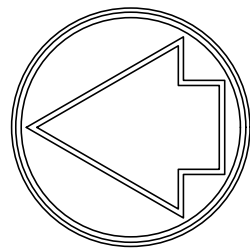

APN 027-155-001

K. NICHOLSON & R. SCHWARTZ

6691 MORO ST. 6691 MORO ST. 6691 MORO ST. 6691 MORO ST. 6691 MORO ST.
REV. 02/07/23 FOUNDATION REV. 02/07/23 FOUNDATION REV. 02/07/23 FOUNDATION REV. 02/07/23 FOUNDATION REV. 02/07/23 FOUNDATION
DATE 02/07/23 DATE 02/07/23 DATE 02/07/23 DATE 02/07/23 DATE 02/07/23
DESCRIPTION FOR PETALUMA, CA 94952 SONOMA - BUILDING PLAN CHECK
APPROVED PLANS AND DOCUMENTS TO BE AVAILABLE ON THE JOB SITE


 
S&B BARN'S
BUILDINGS & FENCE
G. HARTLEY Inc. DBA SC BARN'S LIC# 1072213
3224 DUTTON AVE. SANTA ROSA, CA. 707-523-3513
www.scbarns.com

DATE: 05-03-24
PROJECT NO: 027-155-001
CAD FILE: 027-155-001
DRAWN BY: JS
CHK'D BY: GH
SHEET TITLE

SITE

SHEET OF

W

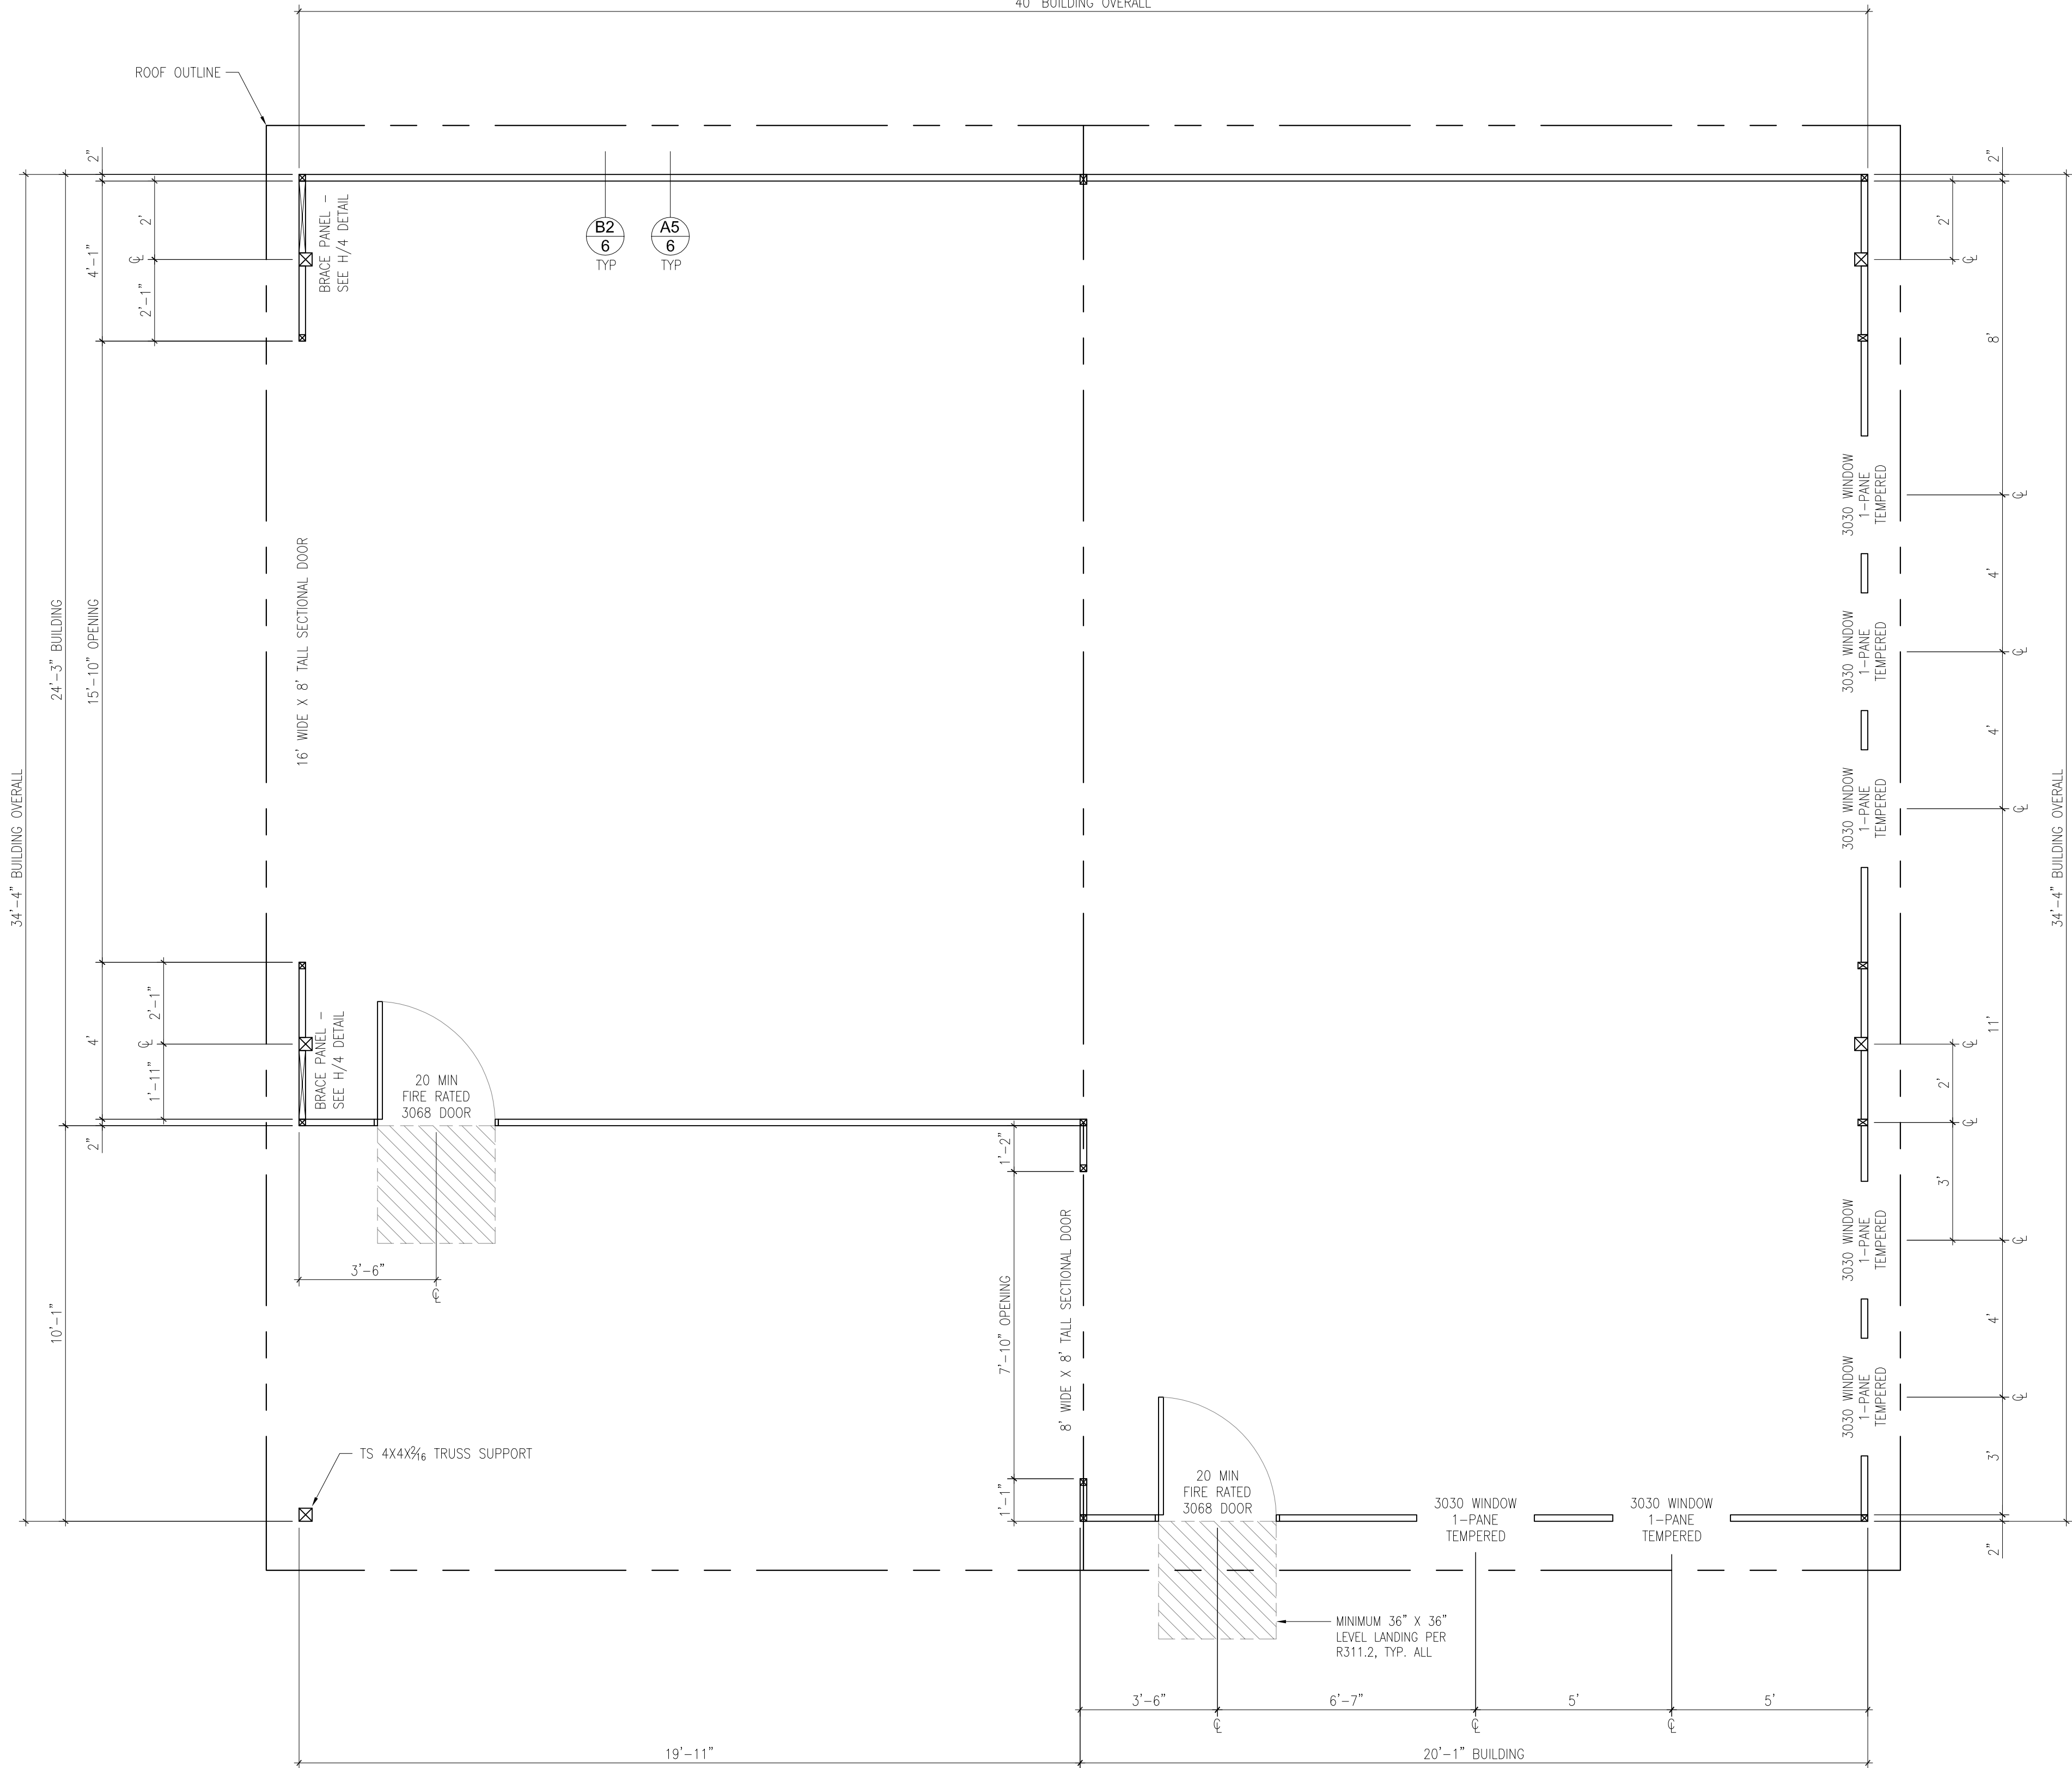


A
3

S

FLOOR PLAN

SCALE 3/8"=1'-0"

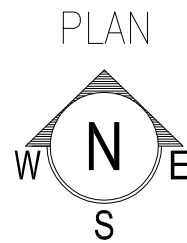


A
3

S

FLOOR PLAN

SCALE 3/8"=1'-0"

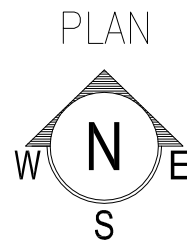

K. NICHOLSON & R. SCHWARTZ
6691 MORO ST
PETALUMA, CA 94952


MARK	DATE	DESCRIPTION
1	06.20.2024	ISSUED FOR PERMIT
2	07.26.2024	REVISION

DATE:	06.20.2024
PROJECT NO:	24-113
CAD FILE:	027-155-001
DRAWN BY:	JS
CHK'D BY:	GH
SHEET TITLE:	

FLOOR PLAN

SHEET 1 OF 6

KAS
Associates, Inc.
ENGINEERING SERVICES
Medford, OR 97504
394 S. Holly Street
Ph: (541) 772-5807
• kas@kasinc.com • www.kasinc.com

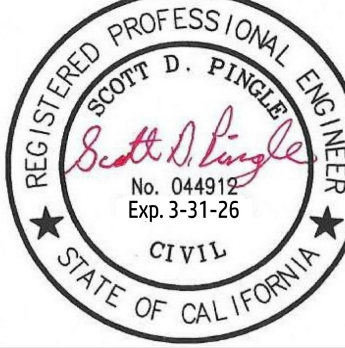

BARN'S
BUILDINGS & FENCE
G. HARLEY, Inc. DBA SC BARN'S LIC#1072213
3224 DUTTON AVE. SANTA ROSA, CA. 707-523-3513
www.scbarns.com

Electrical Key

100' Cable to Main

9 - 110 V Interior

1 - 110 V Exterior

3 - 220V (one for Car Charger)

4 - Exterior Lights

2 - 3way Interior Switch

1 - 3 way Exterior

8 - HB Lights

Address:

6691 Moro St.

Bloomfield
(Petaling)



Electrical Plan

